


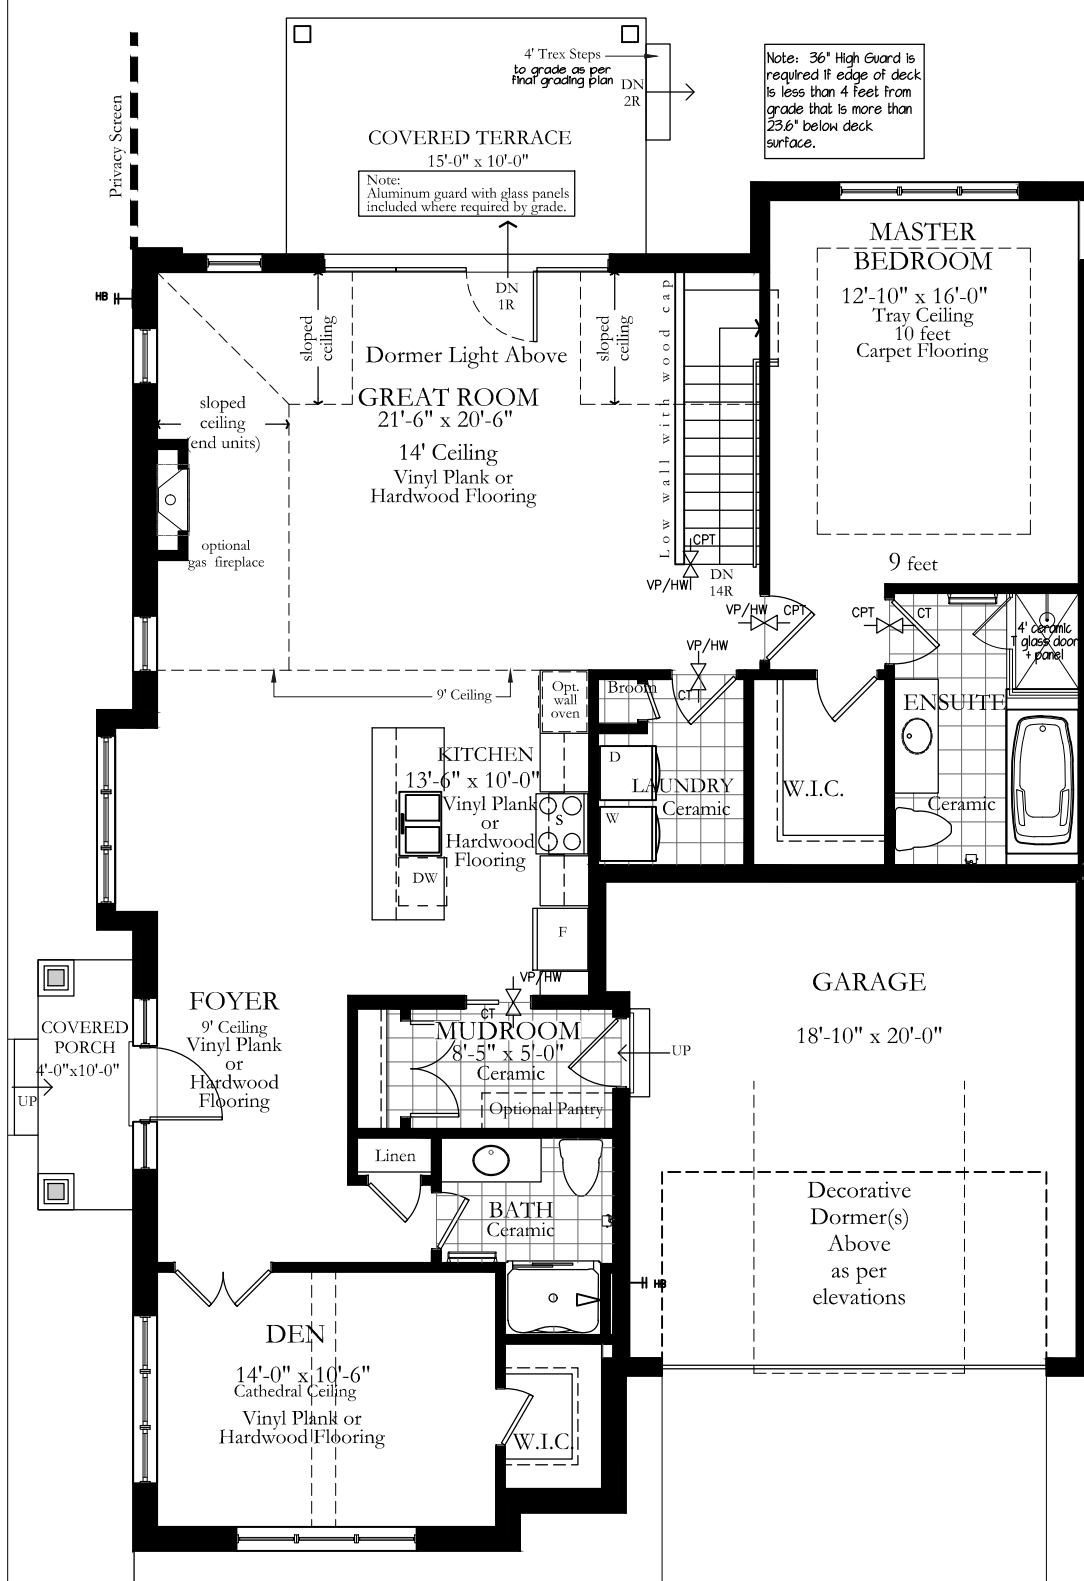


Willow
Main Floor Plan
1615 Square Feet
scale: 1/8"=1'-0"

ELECTRICAL LEGEND				NOTES:		MECHANICAL LEGEND
- RECESSED INTERIOR DOWNLIGHT - RECESSED INTERIOR DOWNLIGHT -VAPOUR PROOF - RECESSED EXTERIOR DOWNLIGHT - SURFACE MOUNTED CEILING INCANDESCENT FIXTURE, RECESSED JUNCTION BOX - INCANDESCENT FIXTURE, WITH PULL CHAIN - TRACK LIGHT	- VAPOUR PROOF SURFACE MOUNTED CEILING INCANDESCENT FIXTURE - RECESSED JUNCTION BOX - EXTERIOR WALL MOUNTED INCANDESCENT FIXTURE - INTERIOR WALL MOUNTED INCANDESCENT FIXTURE - INTERIOR WALL MOUNTED INCANDESCENT FIXTURE 2 LIGHTS - INTERIOR WALL MOUNTED INCANDESCENT FIXTURE 3 LIGHTS - OPTIONAL RECESSED DOWNLIGHTS with DIMMER SWITCH	- UNDERCOUNTER FLOUORESCENT - EXTERIOR FLOOD LIGHT U/SOF ROOF OVERHANG W/MOTION SENSOR - OVERHEAD GARAGE DOOR OPERATOR c/w LIGHT SWITCH - SWITCH-FIREPLACE 3 WAY SWITCH - DIMMER SWITCH	- DOOR ACTIVATED LIGHT 110V DUPLEX OUTLET 220V APPLIANCE - EXTERIOR WATER PROOF/GFI OUTLET - BATHROOM GROUND FAULT OUTLET - COUNTER HEIGHT GROUND FAULT OUTLET - FLOOR OUTLET	- BOX FOR FUTURE VEHICLE CHARGING - SMOKE/CARBON MONOXIDE DETECTOR - EXHAUST FAN - CHIME - RECESSED CEILING SPEAKER - CENTRAL VACUUM OUTLET		- TELEPHONE - CABLE - WHIRLPOOL MOTOR - CEILING FAN


1. ALL EXTERIOR RECEPTACLES TO BE WATERPROOF, GFI.
2. ALL KITCHEN RECEPTACLES TO BE GFI AND MOUNTED 45" ABOVE THE FINISHED FLOOR WHERE ADJACENT TO CABINETS. REFER TO KITCHEN LAYOUTS FROM KITCHEN MANUFACTURER FOR LOCATIONS AS WELL AS FOR APPLIANCE LOCATIONS.
3. ALL BEDROOM OUTLETS TO BE "I" PROTECTED.
4. ALL SHOWER FIXTURES TO BE VAPOUR/WATER PROOF.
5. ALL BATHROOM & LAUNDRY ROOM OUTLETS TO BE GFI AND MOUNTED ABOVE COUNTER HEIGHT WHERE APPLICABLE. REFER TO MILLWORK DRAWINGS.
6. ELECTRICAL CONTRACTOR TO COORDINATE THERMOSTAT, CHIME AND SWITCH LOCATIONS WITH SITE SUPERINTENDENT.
7. 200 AMP PANEL WITH CONDUIT TO SQUARE 4 11/16" BOX IN GARAGE FOR FUTURE ELECTRIC VEHICLE CHARGING.

- HOSE BIB (FROST PROOF)
- ENERGY RECOVERY VENTILATOR
- THERMOSTAT
- FIREPLACE THERMOSTAT
- EXHAUST FAN

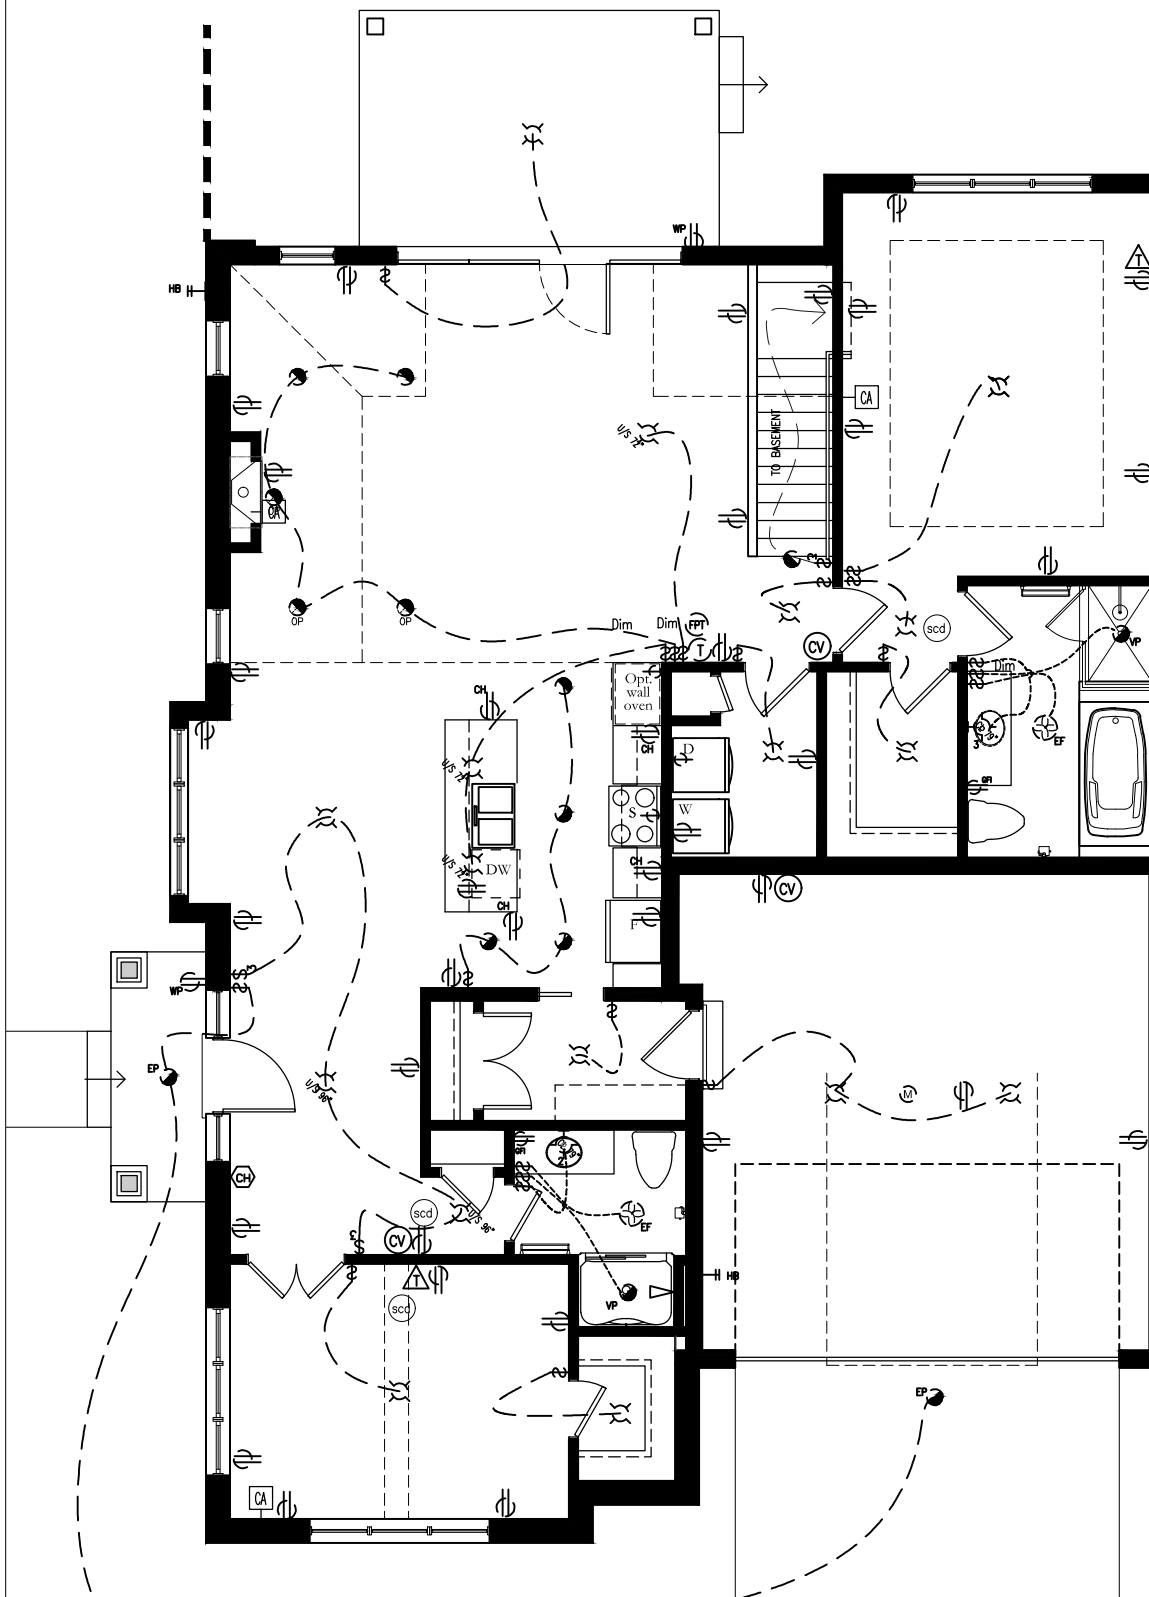

Willow
Main Floor Plan
Electrical Concept Plan
Actual may vary.
scale: 1/8"=1'-0"




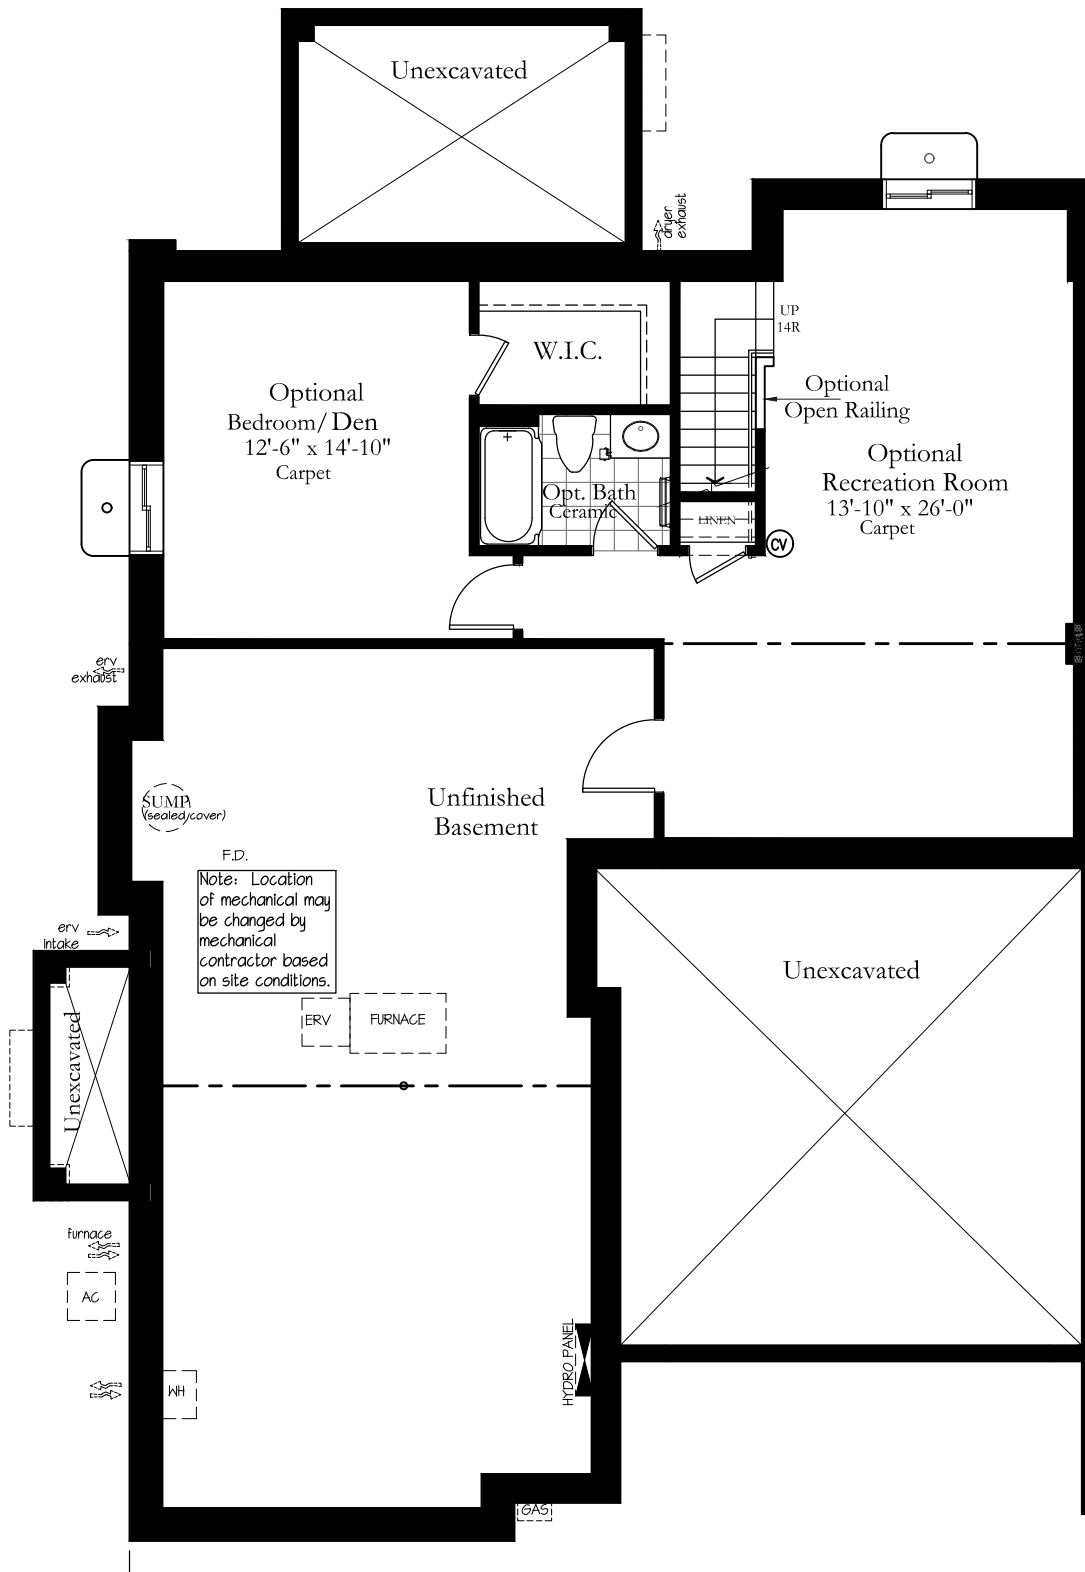

Willow
Optional
Basement Floor Plan
scale: $\frac{1}{8}" = 1'-0"$



ELECTRICAL LEGEND				NOTES:		MECHANICAL LEGEND
RECESSED INTERIOR DOWNLIGHT	VAPOUR PROOF SURFACE MOUNTED CEILING INCANDESCENT FIXTURE	UNDERCOUNTER FLOURESCENT	DOOR ACTIVATED LIGHT	1. ALL EXTERIOR RECEPTACLES TO BE WATERPROOF, GFI, 45" ABOVE THE FINISHED FLOOR WHERE ADJACENT TO CABINETS. REFER TO KITCHEN LAYOUTS FROM KITCHEN MANUFACTURER FOR LOCATIONS AS WELL AS FOR APPLIANCE LOCATIONS.	2. HOSE BIB (FROST PROOF)	ENERGY RECOVERY VENTILATOR
RECESSED INTERIOR DOWNLIGHT -VAPOUR PROOF	RECESSED JUNCTION BOX	EXTERIOR FLOOD LIGHT U/SOF ROOF OVERHANG	110V DUPLEX OUTLET	3. ALL BEDROOM OUTLETS TO BE '1' PROTECTED.	3. THERMOSTAT	FIREPLACE THERMOSTAT
RECESSED EXTERIOR DOWNLIGHT	EXTERIOR WALL MOUNTED INCANDESCENT FIXTURE	W/MOTION SENSOR	220V APPLIANCE	4. ALL SHOWER FIXTURES TO BE VAPOUR/WATER PROOF.	4. EXHAUST FAN	EXHAUST FAN
SURFACE MOUNTED CEILING INCANDESCENT FIXTURE, RECESSED JUNCTION BOX	INTERIOR WALL MOUNTED INCANDESCENT FIXTURE	OVERHEAD GARAGE DOOR OPERATOR c/w LIGHT SWITCH	EXTERIOR WATER PROOF/GFI OUTLET	5. ALL BATHROOM & LAUNDRY ROOM OUTLETS TO BE GFI AND MOUNTED ABOVE COUNTER HEIGHT WHERE APPLICABLE. REFER TO MILLWORK DRAWINGS.	5. WHIRLPOOL MOTOR	
INCANDESCENT FIXTURE, WITH PULL CHAIN	INTERIOR WALL MOUNTED INCANDESCENT FIXTURE 2 LIGHTS	SWITCH-FIREPLACE	BATHROOM GROUND FAULT OUTLET	6. ELECTRICAL CONTRACTOR TO COORDINATE THERMOSTAT, CHIME AND SWITCH LOCATIONS WITH SITE SUPERINTENDENT.	6. CHIME	
TRACK LIGHT	INTERIOR WALL MOUNTED INCANDESCENT FIXTURE 3 LIGHTS	3 WAY SWITCH	COUNTER HEIGHT GROUND FAULT OUTLET	7. 200 AMP PANEL WITH CONDUIT TO SQUARE 4 11/16" BOX IN GARAGE FOR FUTURE ELECTRIC VEHICLE CHARGING.	7. RECESSED CEILING SPEAKER	
	OPTIONAL RECESSED DOWNLIGHTS with DIMMER SWITCH	DIMMER SWITCH	FLOOR OUTLET		8. CEILING FAN	
					9. CENTRAL VACUUM OUTLET	

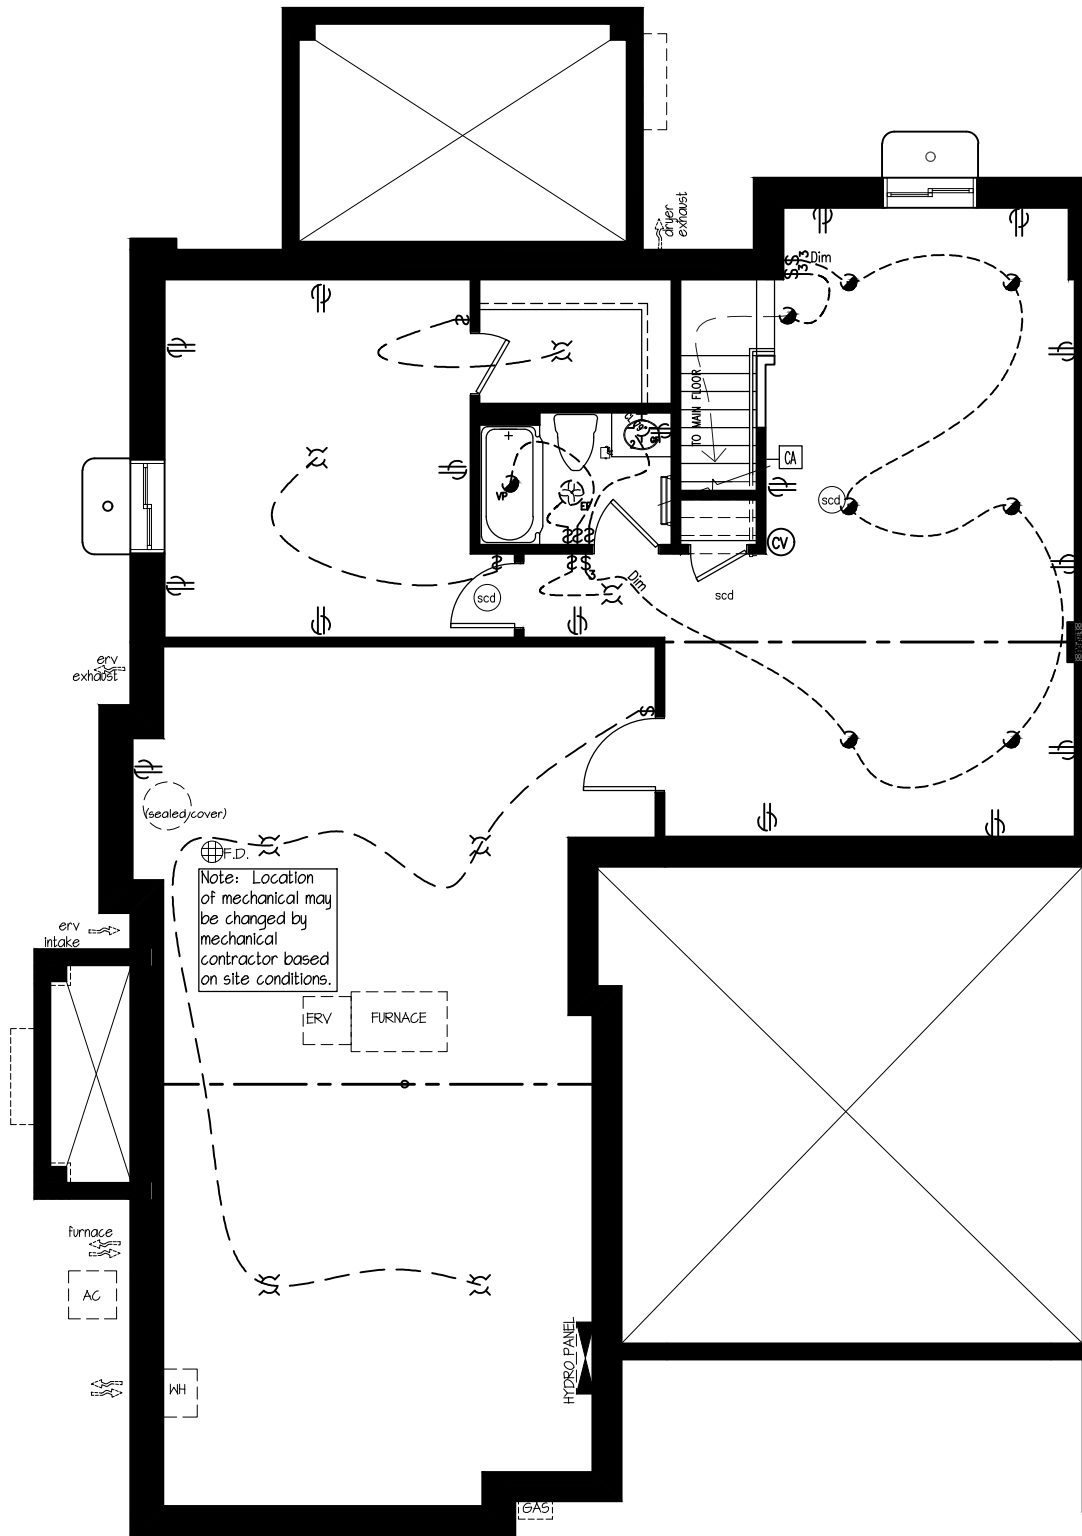

Willow
Optional
Basement Floor Plan
Electrical Concept Plan
Actual may vary.
scale: 1/8"=1'-0"






Willow
Front Elevation
scale: $\frac{1}{8}"=1'-0"$





Willow
Side Elevation
not to scale

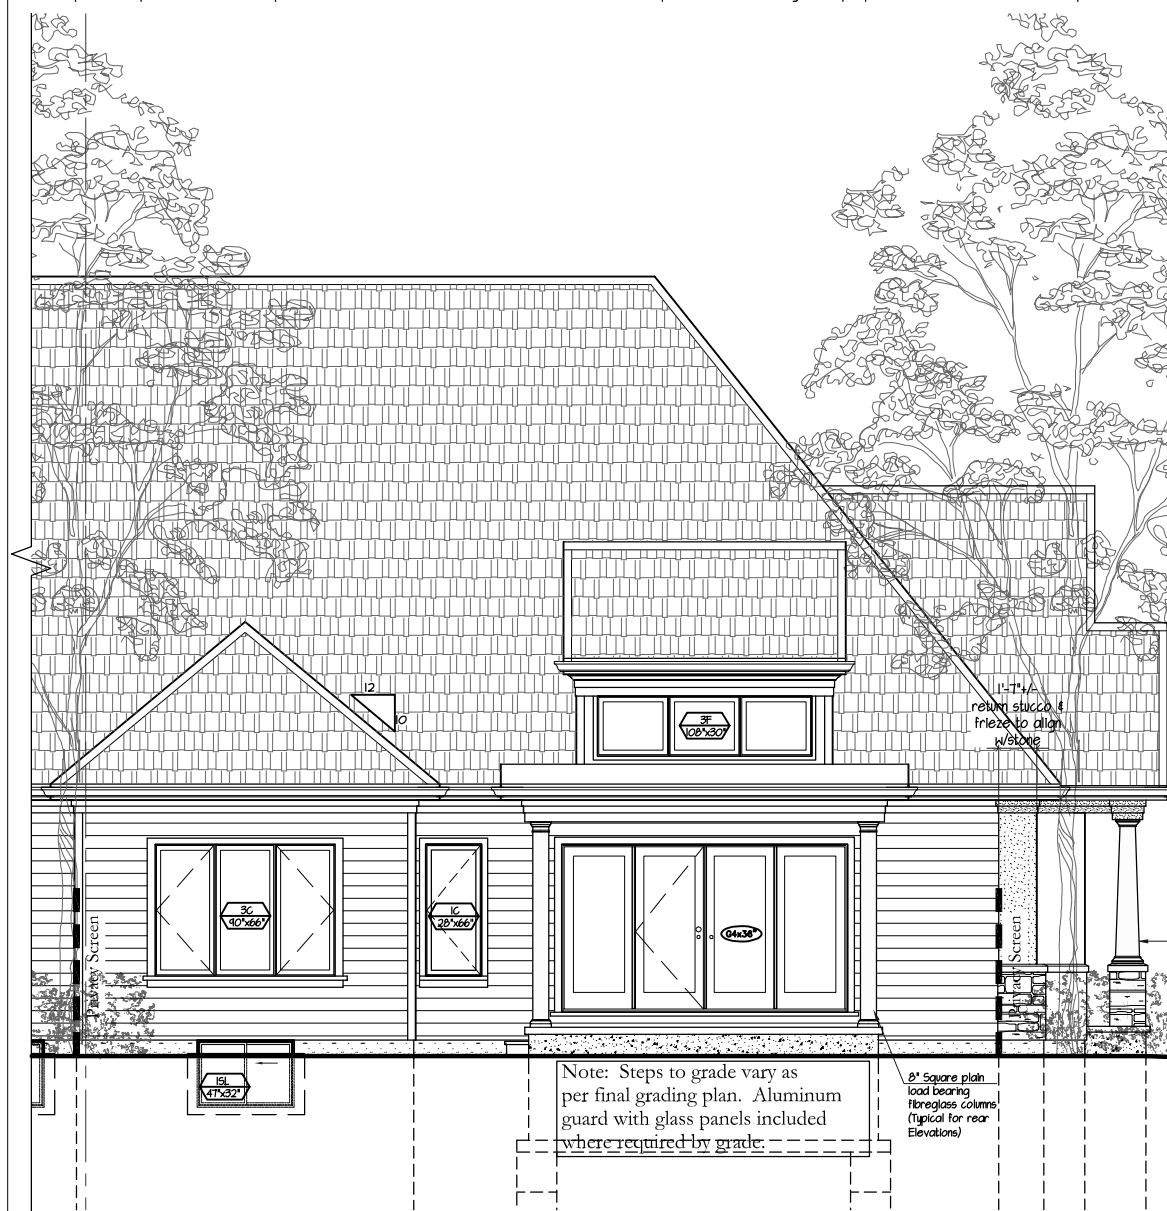

Willow
Rear Elevation
scale: $\frac{1}{8}" = 1'-0"$

